


This design or drawing is the sole property of Calamba Water District. No part of this design or drawing may be reproduced or transmitted in any form or by any means without the written consent of its owner.

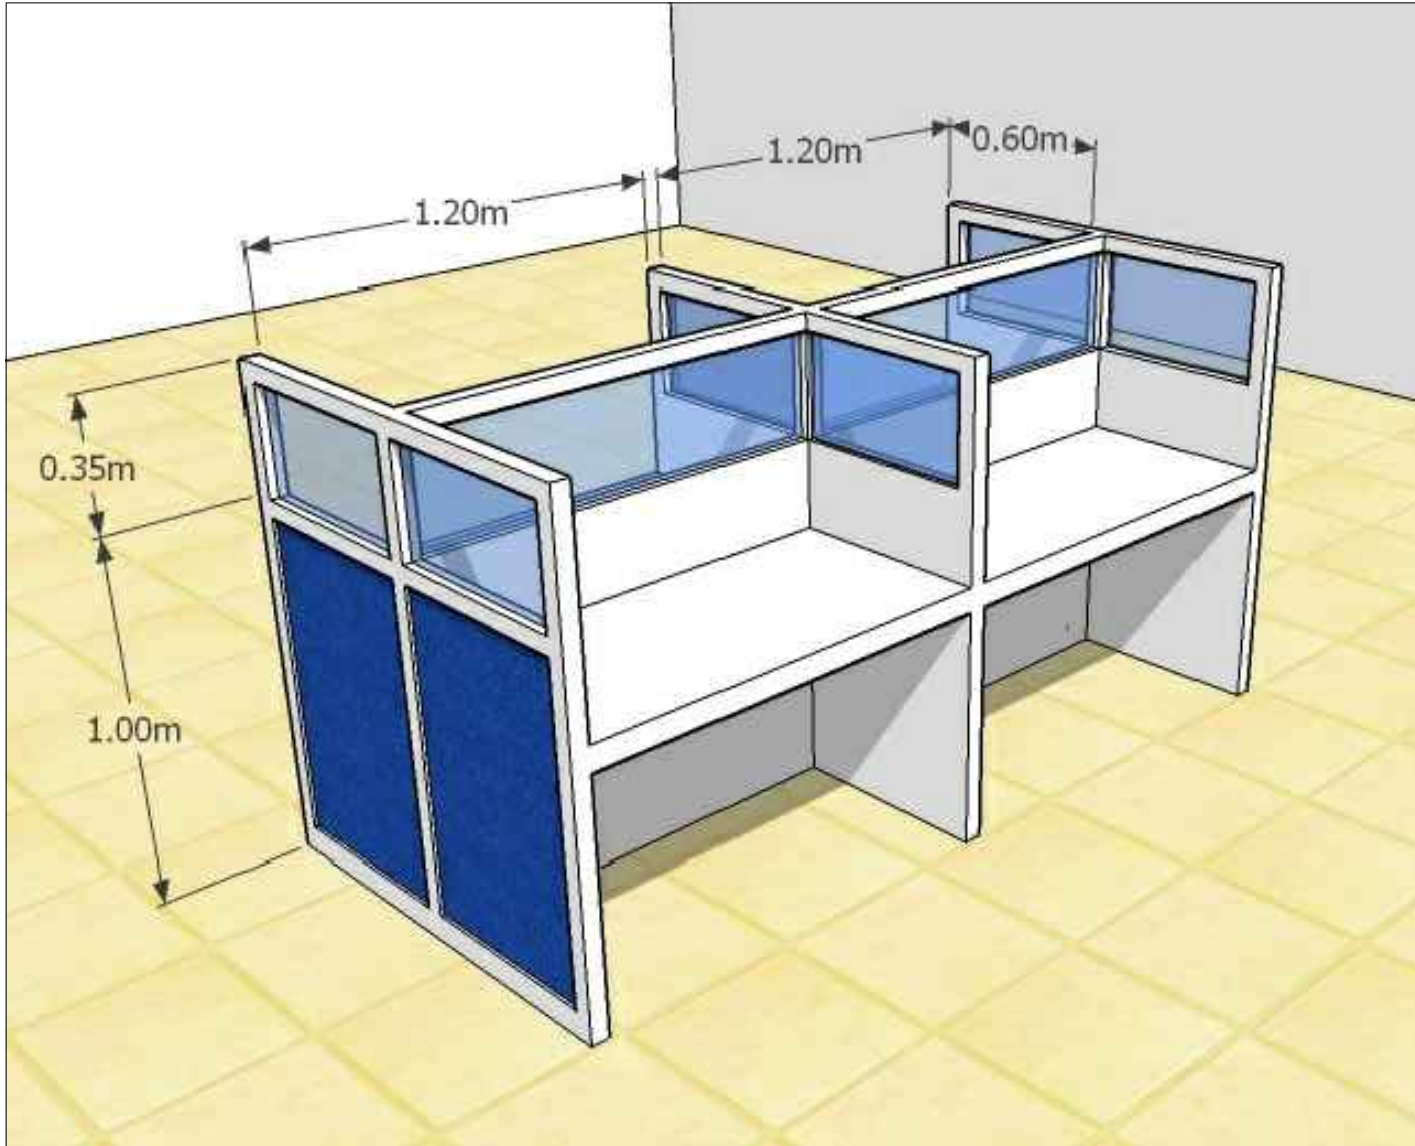

**CALAMBA WATER DISTRICT**  
ENGINEERING DEPARTMENT  
PLANNING AND DESIGN DIVISION

247 Public Service

LAKEVIEW SUBD., HALANG, CALAMBA CITY

PROJECT TITLE:

PROPOSED MULTIPLE MODULAR TABLE

LOCATION:

CALAMBA WATER DISTRICT

DRAWN BY:

A. DEL PRADO

DESIGNED BY:

-

CHECKED BY:

ENGR. J. GILLERA

RECOMMENDED BY:

ENGR. J. GILLERA

APPROVED BY:

MR. E. A. AGUILAR JR.

SHEET CONTENTS:

FLOOR PLAN

DATE:

SHEET NO.

1